

ADJUSTMENTS

Add an adjustment

- Levels Presets
- Curves Presets
- Exposure Presets
- Hue/Saturation Presets
- Black & White Presets
- Channel Mixer Presets
- Selective Color Presets

CHARACTER PARAGRAPH

0 pt 0 pt

0 pt 0 pt

0 pt 0 pt

Hyphenate

COLOR SWATCHES STYLES

R 255

G 255

B 255

NAVIGATOR HIST MASH INFO PATH




100%

LAYERS CHANNELS

Normal Opacity: 100%



Lock: Fill: 100%

- LWCF - Sawyer 14 Acres
- LWCF - Sawyer - 20 acres
- LWCF - Sawyer Shading
- LWCF - Feuer Shading
- LWCF - Recreation Lands
- Petingale Land
- Trinity Camp Land
- Rick Schafer's Land
- Shape 2
- Shape 1
- Dicky ROW
- Conso wetland - blue
- Condo wetland - gray
- Condo land - white
- White Surround
- Background Copy

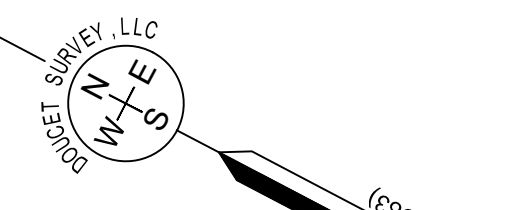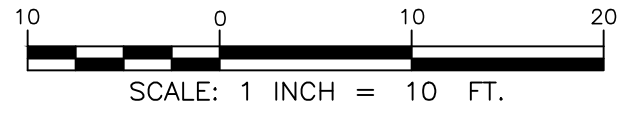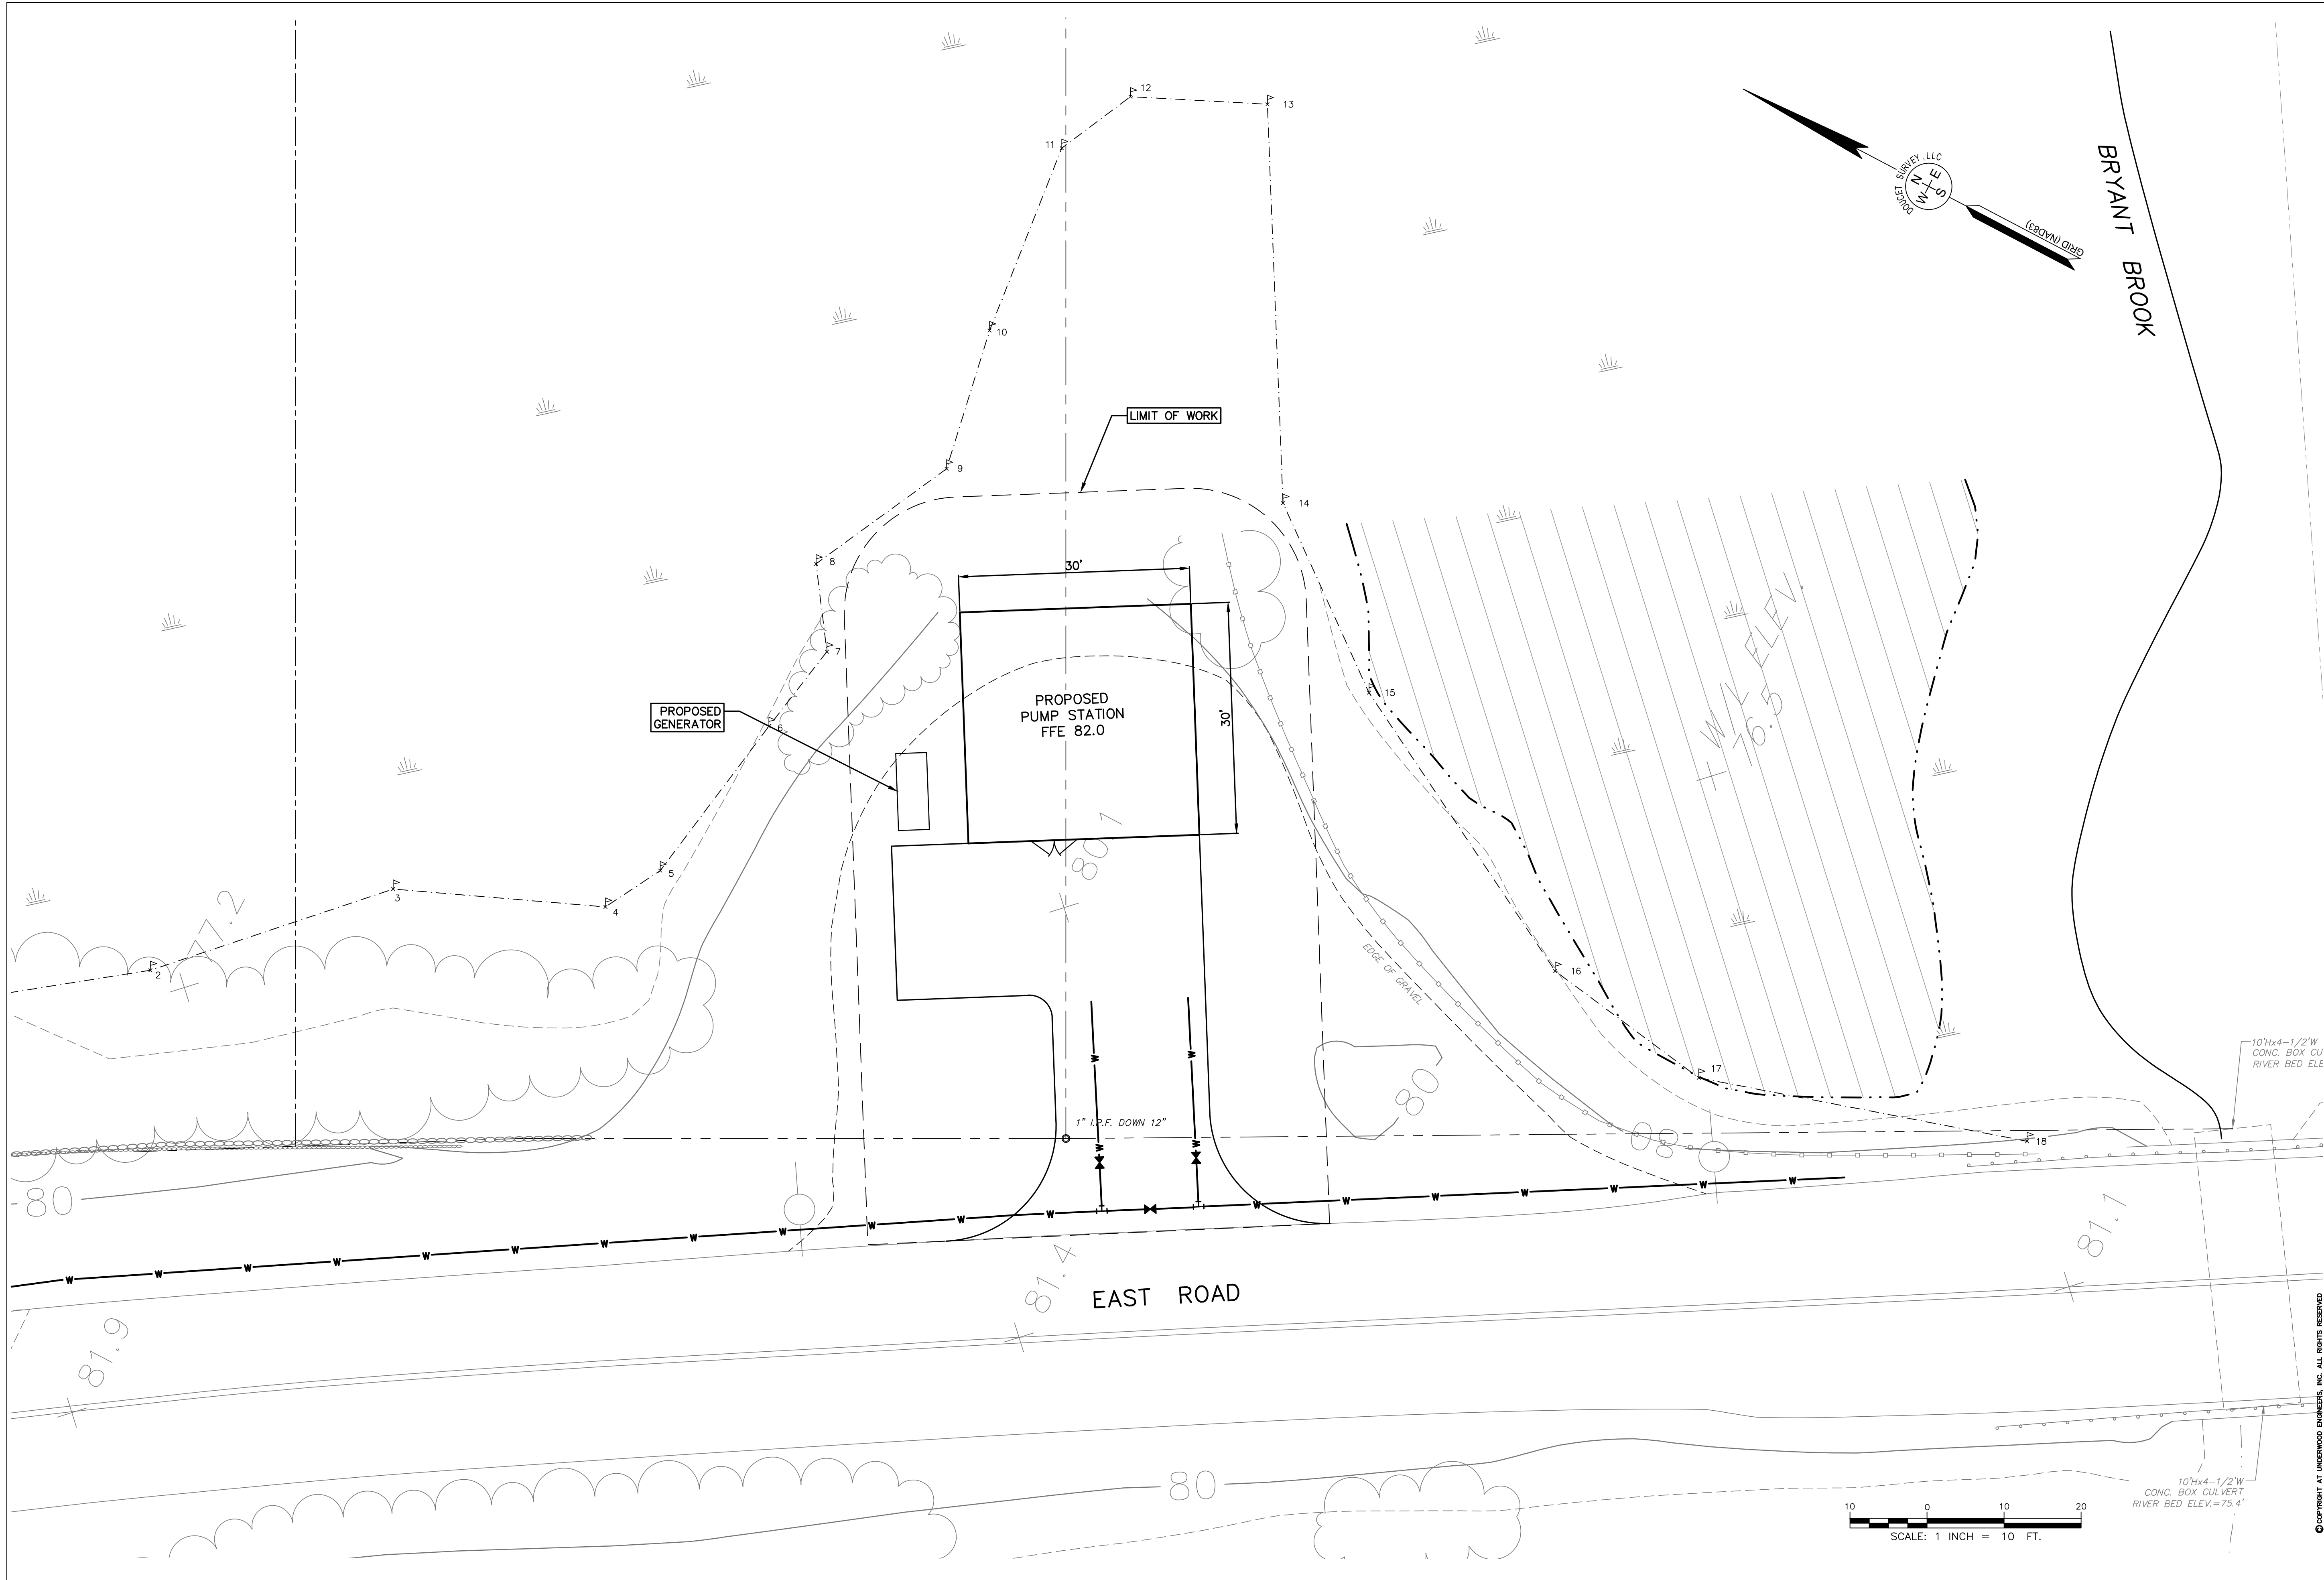

DWG NO	SHEET OF	PUMP STATION SITE PLAN	SOUTHERN NH REGIONAL WATER IMPROVEMENTS CONTRACT P2 - PUMP STATION	TOWN OF PLAISTOW, NEW HAMPSHIRE	
<p style="text-align: center; font-size: small;">25 Vaughan Mall, Portsmouth, N.H. 03801 Tel. 603-436-6192 Fax. 603-431-4733</p>					
<p style="margin: 0;">60% SUBMITTAL</p> <p style="margin: 0;">OCTOBER 2019</p> <p style="margin: 0;">NOT FOR CONSTRUCTION</p>					
Drawn/Chk. HAV	DESIGNED	Checked E.F.	Approved TGP	Date OCTOBER 2019	Project No. 2384
Book No.	Dwg. ID	Scale	AS SHOWN	NO.	REVISIONS
APPROVAL	Date	By	CONSTRUCTION	Date	By
RECORD DRAWING	Date	By	APP'D	NO.	REVISIONS

M:\Real Numbers\PLAISTOW\2384_P2\36\2384PSSITE.dwg, 10/23/2019 1:21:36 PM

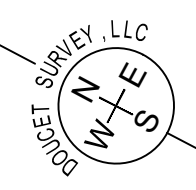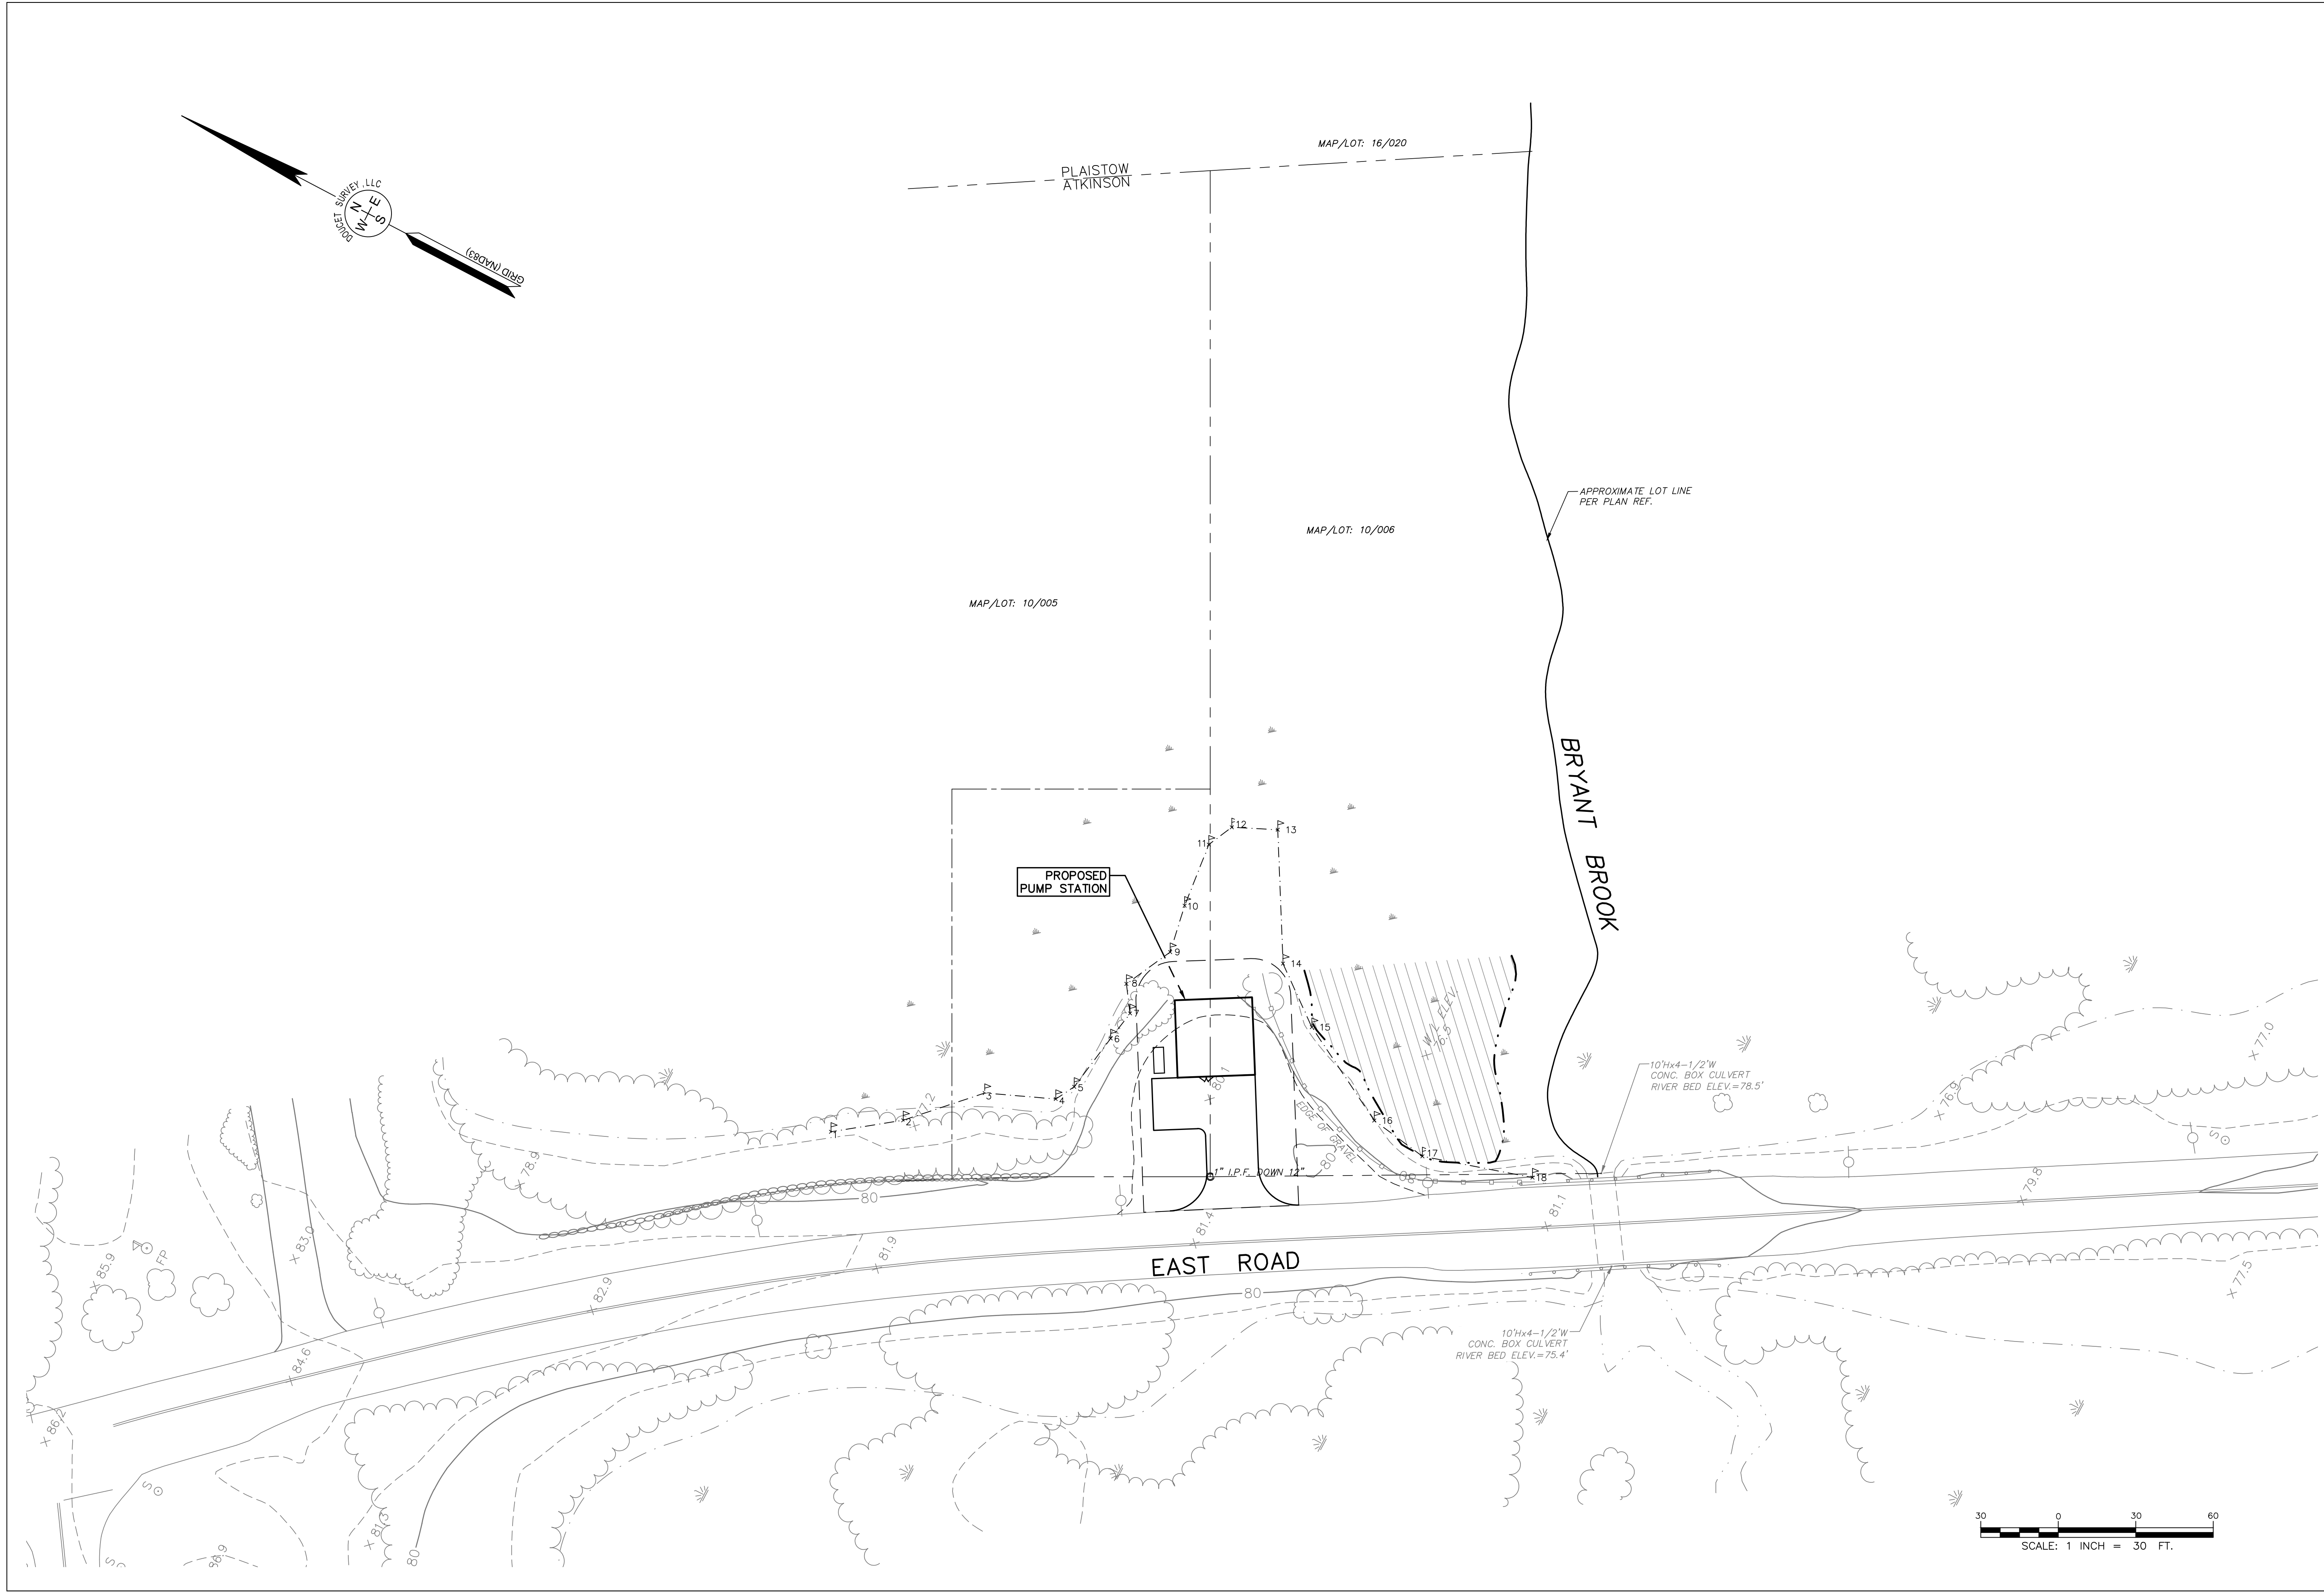

60% SUBMITTAL
OCTOBER 2019
NOT FOR CONSTRUCTION

UNDERWOOD
engineers

25 Vaughan Mall, Portsmouth, N.H. 03801
 Tel. 603-436-6192 Fax. 603-431-4733

PUMP STATION SITE PLAN OVERVIEW
 SOUTHERN NH REGIONAL WATER IMPROVEMENTS
 CONTRACT P2 - PUMP STATION
 TOWN OF PLAISTOW, NEW HAMPSHIRE

Drawn/Chk. HAV	ISSUE FOR
Designed DWS	APPROVAL
Checked E.F.	Date
Approved TGP	By
Date OCTOBER 2019	CONSTRUCTION
Book No. 2384	Date
Project No. 2384	By
Dwg. ID 2384PSSITE	RECORD DRAWING
Scale AS SHOWN	Date
	By
	APP'D
	NO.
	REVISIONS
	NO.